


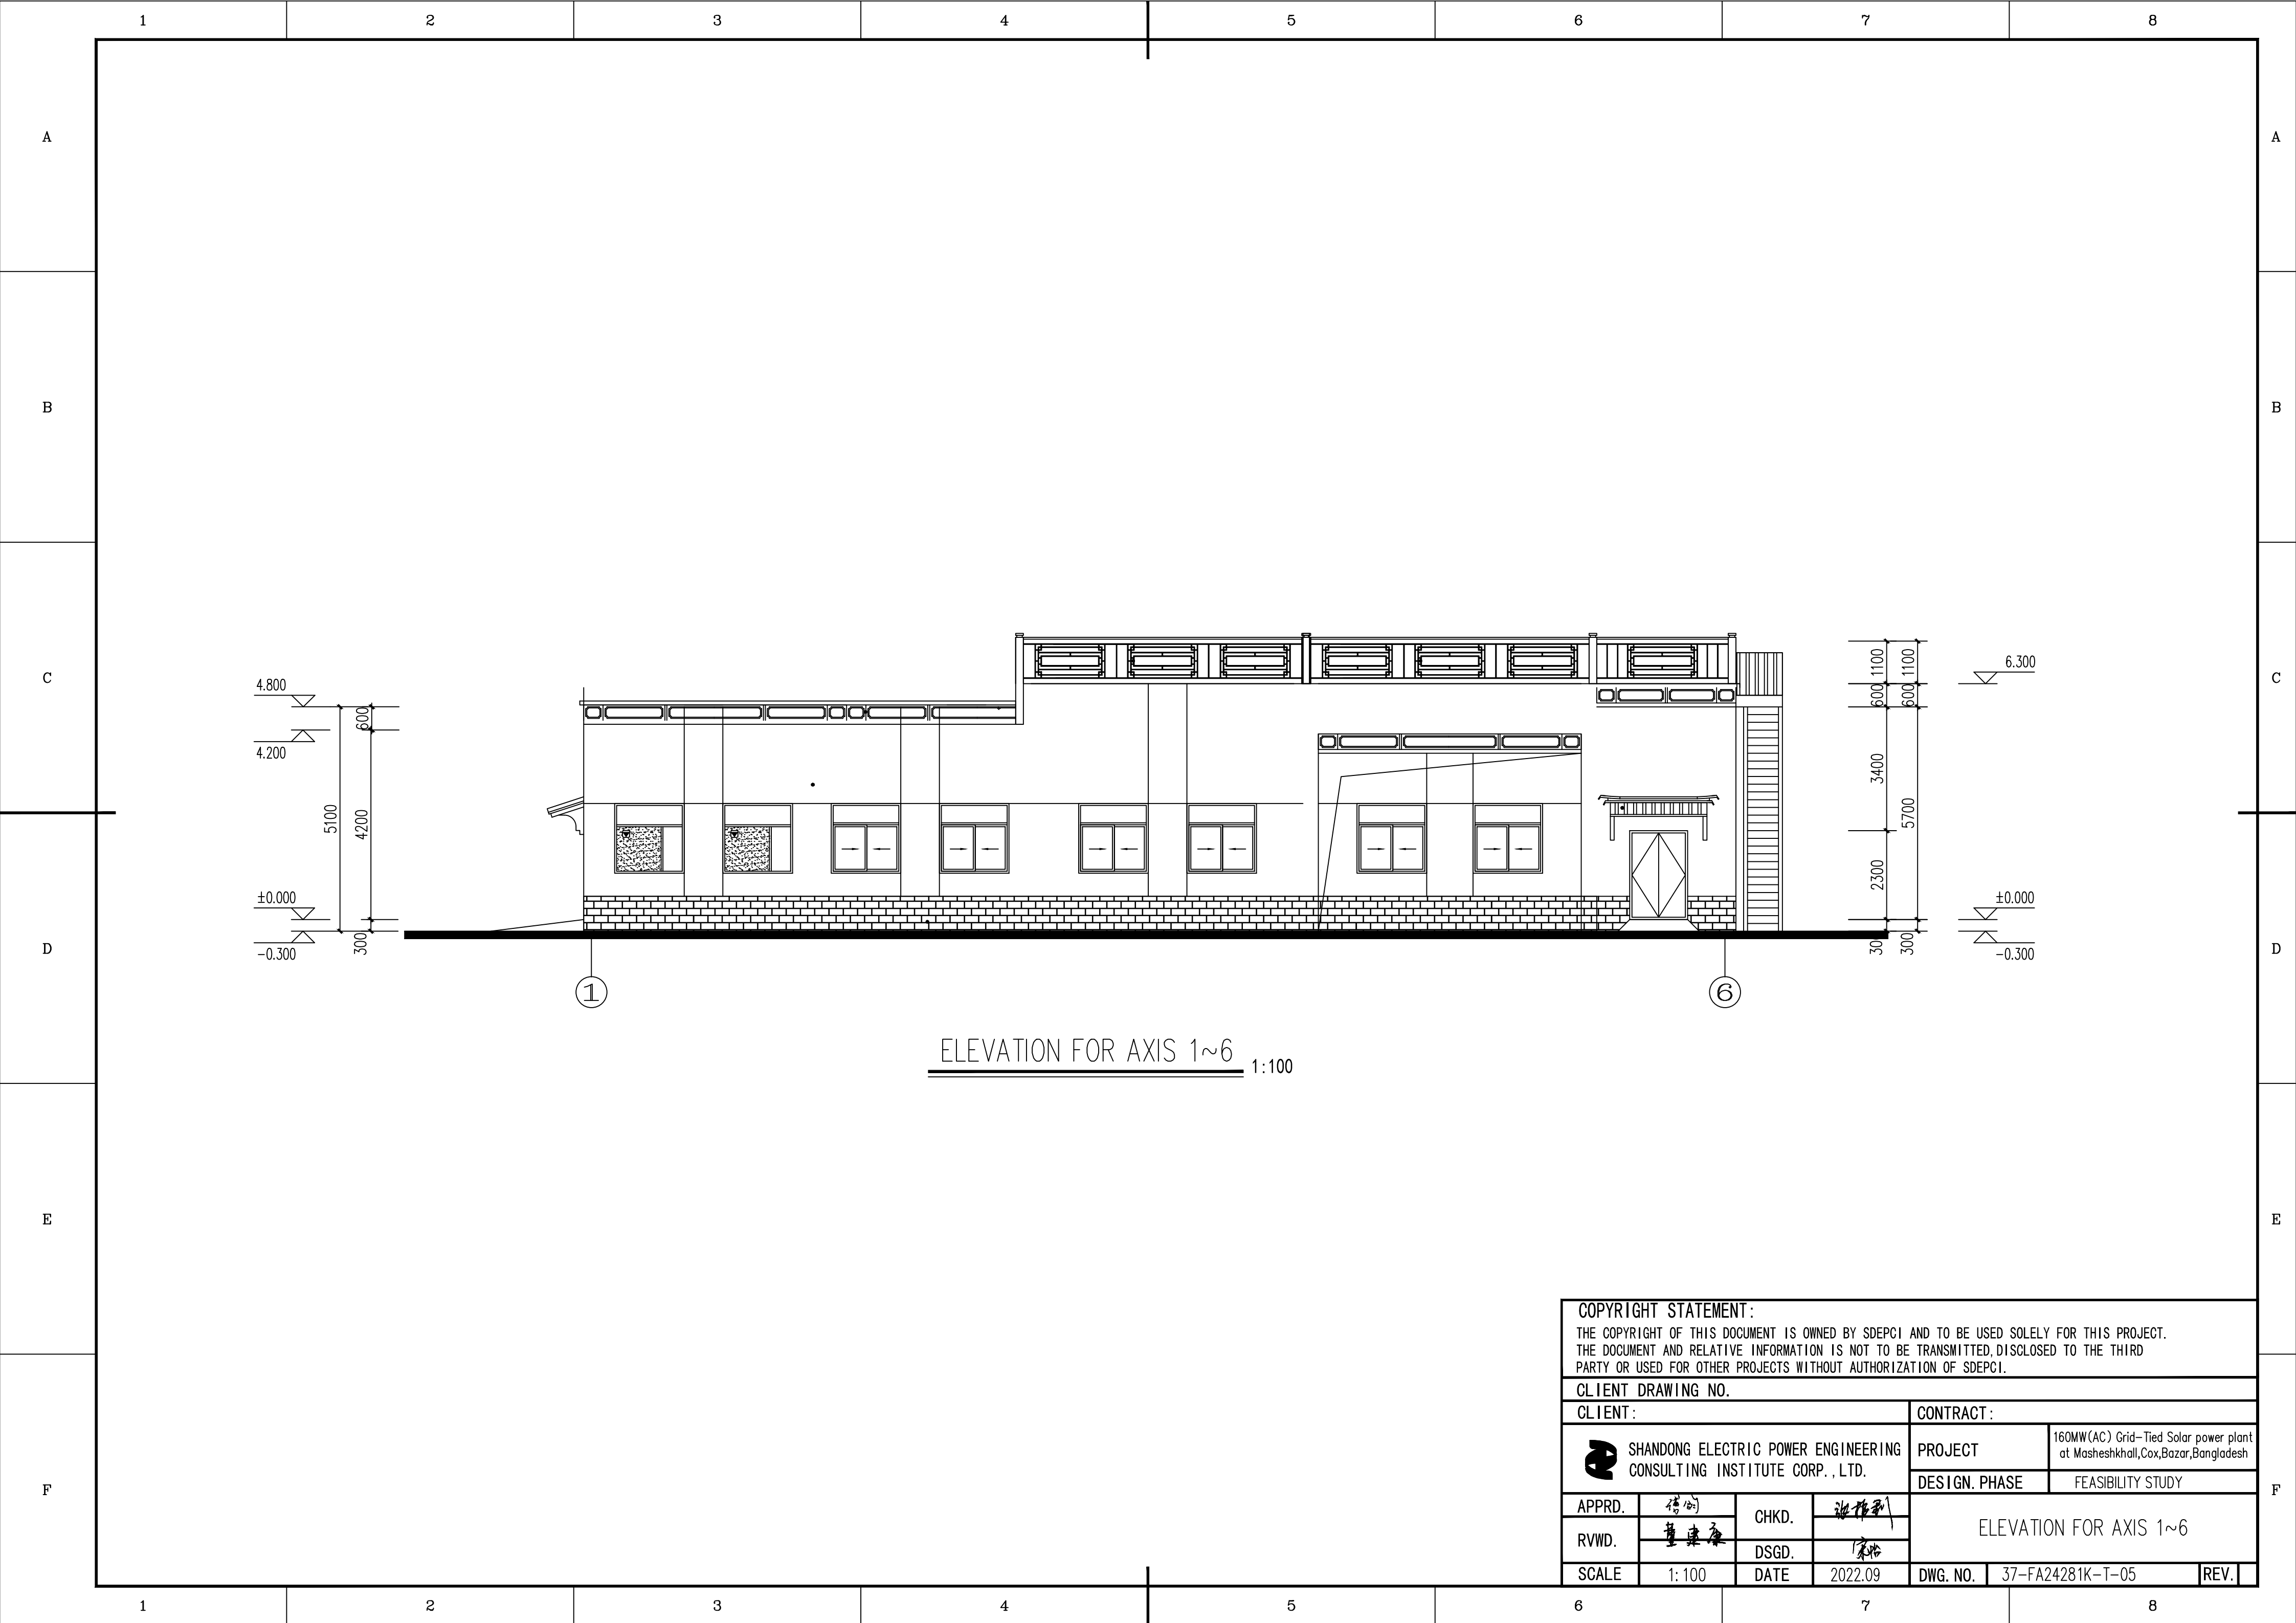

COPYRIGHT STATEMENT: THE COPYRIGHT OF THIS DOCUMENT IS OWNED BY SDEPCI AND TO BE USED SOLELY FOR THIS PROJECT. THE DOCUMENT AND RELATIVE INFORMATION IS NOT TO BE TRANSMITTED, DISCLOSED TO THE THIRD PARTY OR USED FOR OTHER PROJECTS WITHOUT AUTHORIZATION OF SDEPCI.							
CLIENT DRAWING NO.							
CLIENT:				CONTRACT:			
	SHANDONG ELECTRIC POWER ENGINEERING CONSULTING INSTITUTE CORP., LTD.			PROJECT	160MW(AC) Grid-Tied Solar power plant at Masheshkhall, Cox,Bazar, Bangladesh		
				DESIGN. PHASE	FEASIBILITY STUDY		
APPRD.	傅明	CHKD.	张作平	ELEVATION FOR AXIS 1~6			
RVWD.	董建康		DSGD.				
SCALE	1: 100	DATE	2022.09	DWG. NO.	37-FA24281K-T-05	REV.	