



NOTE:
 1. THE APPLICANT HAS RIGHT TO BE USED PROPOSED REFRIGERANT GAS CYLINDER STORAGE.
 2. VENTILATOR COVERED WITH TWO THICK OF FINE COPPER OR BRASS WIRE GALIZE OF MESH NOT LESS THAN 11 TO THE LINEAR C.M.


NOTE:
 FLAME PROOF ELECTRIC LIGHT & ITS ACCESSORIES ONLY WILL BE INSTALLED INSIDE THIS GODOWN. NO OTHERS ORDINARY ELECTRIC LIGHT, PLUG, FUSE, SWITCH, SOCKET OR OPEN LIGHT WILL NOT BE INSTALLED INSIDE THIS GODOWN.

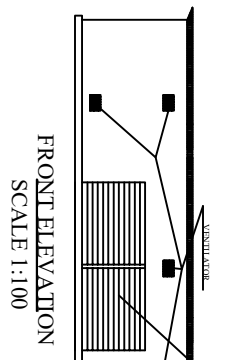


FRONT ELEVATION
 SCALE 1:100

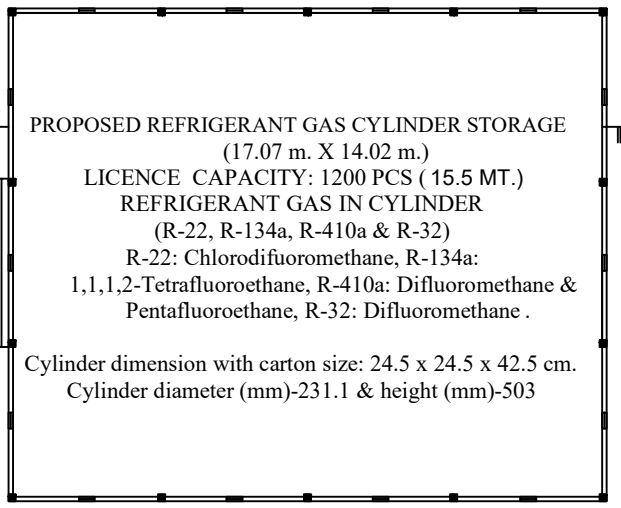


PLAN OF STORAGE
 SCALE 1:100

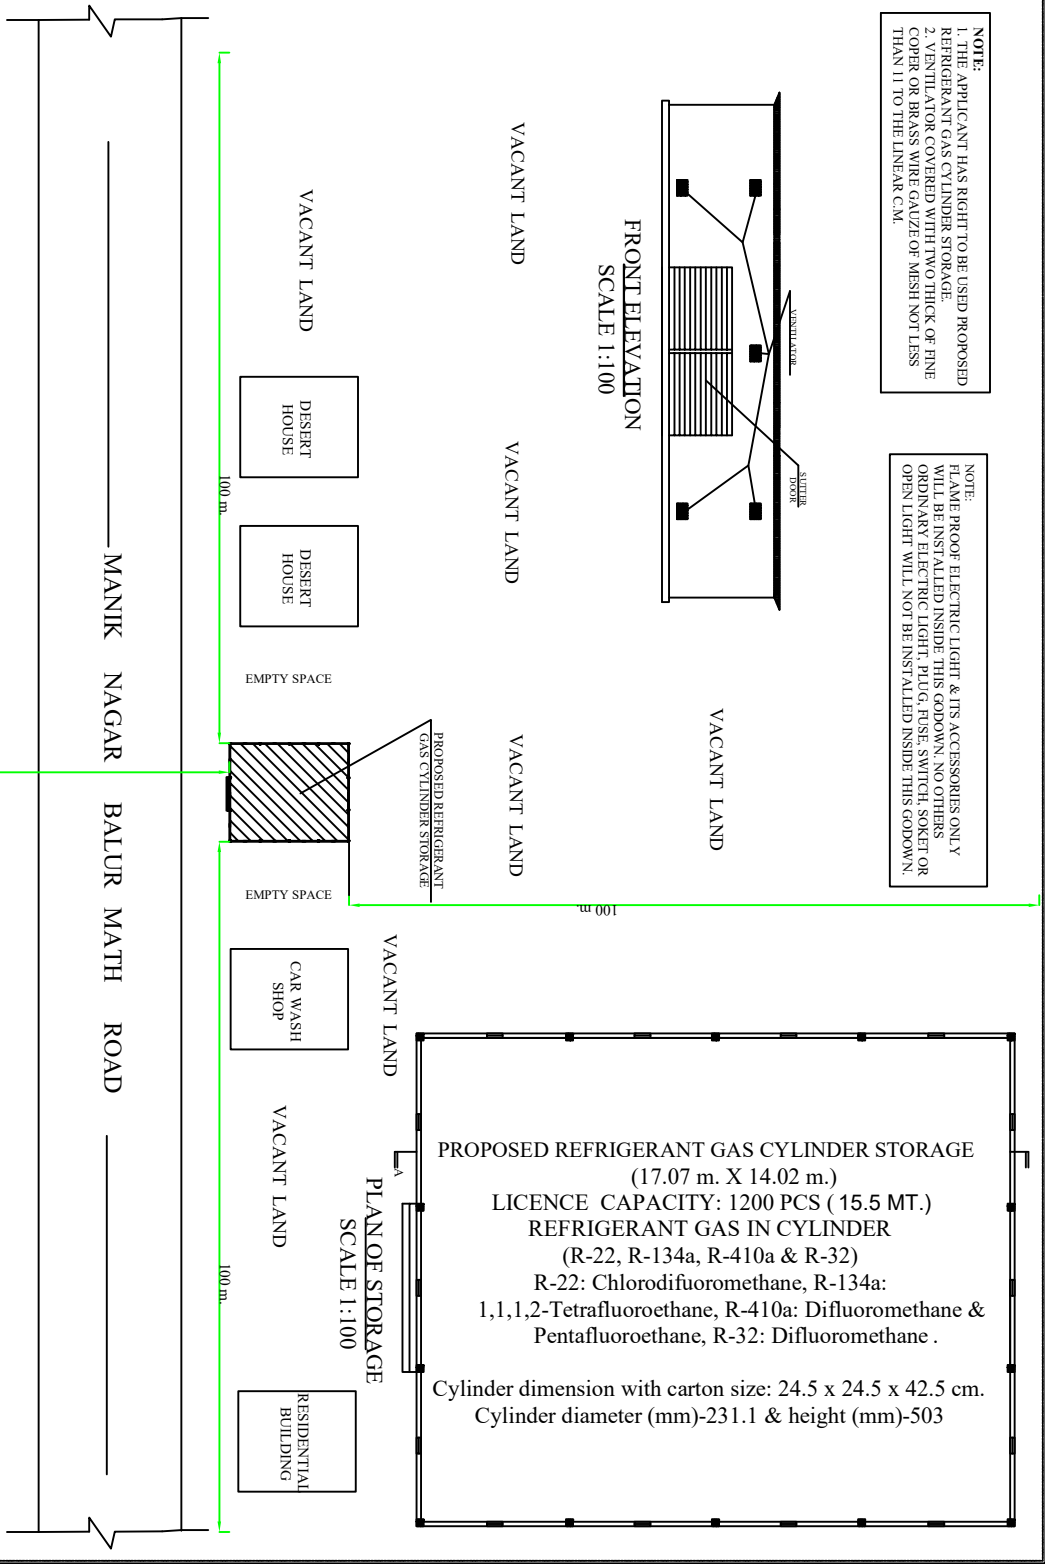

MANIK NAGAR BALUR MATH ROAD

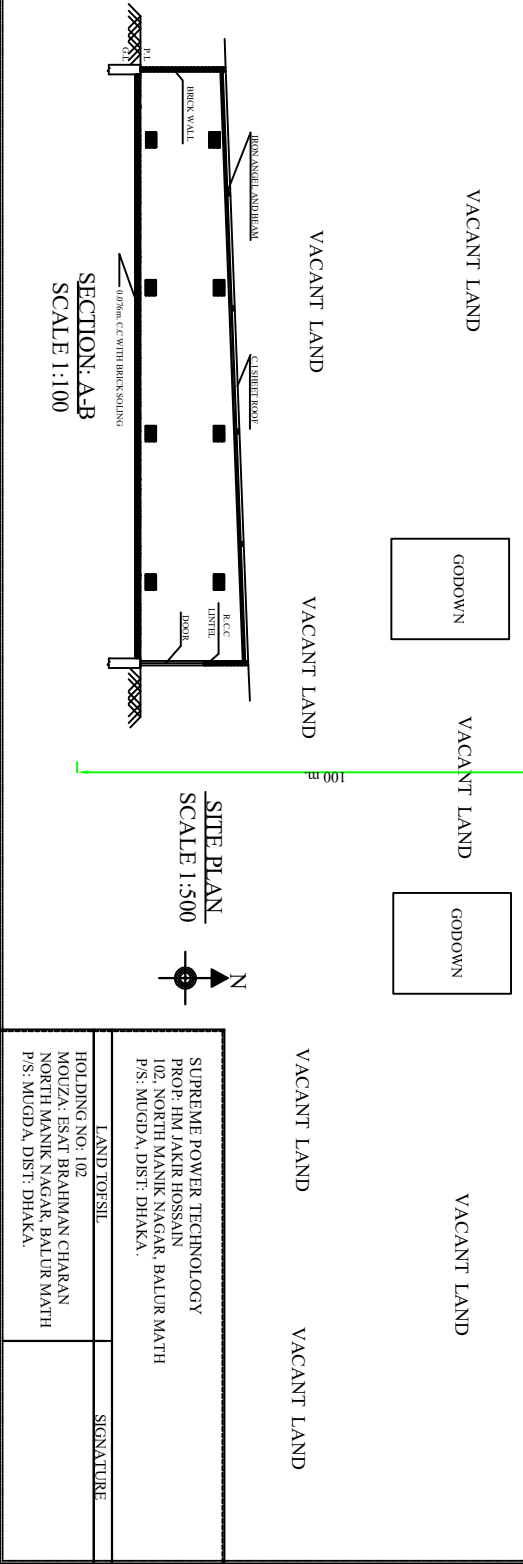

SITE PLAN
 SCALE 1:500

 

SUPREME POWER TECHNOLOGY PROP: HMJ JAKIR HOSSAIN 102, NORTH MANIK NAGAR, BALUR MATH P/S: MUGDA, DIST: DHAKA.		SIGNATURE
HOLDING NO: 102 MOUZA: ESAT BRAHMAN CHARAN NORTH MANIK NAGAR, BALUR MATH P/S: MUGDA, DIST: DHAKA.		