


CONSULTANT

Part A: SHELTECH (PVT.) LTD, THE DECODE LTD. Part B: DDC LTD.

Detailed Area Plan (2022-2035) for RAJUK Area

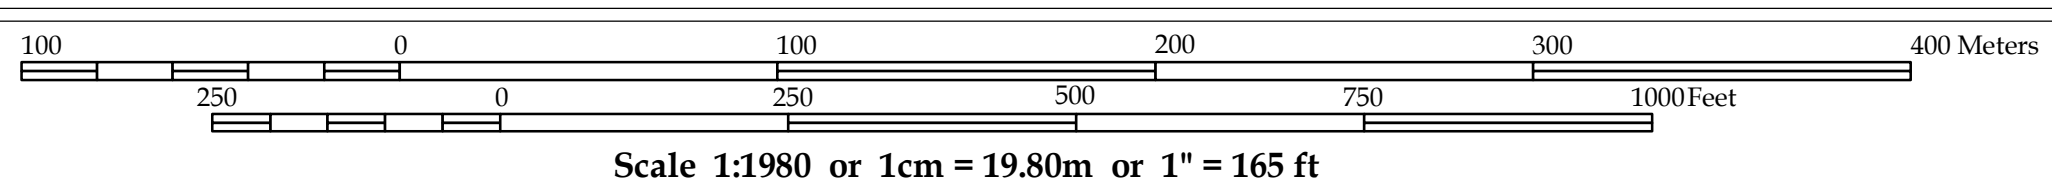

Scale 1:1980 or 1cm = 19.80m or 1" = 165 ft

LEGEND

Legend table with categories: Administrative Boundary, Existing Key Features, Proposed Key Facilities, Proposed Networks, Landuse Management Zone, and Overlay Zone.




Government of the People's Republic of Bangladesh, Ministry of Housing and Public Works, Rajdhani Unnayan Karttripakkha (RAJUK)

Data Source: Stereo satellite image based field survey (2015-17) under DAP (2022-2035) Project of RAJUK

Projection: Transverse Mercator, False Easting: 500000.0, False Northing: 0.0, Central Meridian: 93.0, Scale Factor: 0.9996, Latitude of Origin: 0.0, Linear Unit: Meter (1.0), Geographic Coordinate System: GCS_WGS_1984, Angular Unit: Degree (0.0174532925199433), Prime Meridian: Greenwich (0.0), Datum: D_WGS_1984, Spheroid: WGS_1984, Grid values are shown in Meter

Table with columns for CONSULTANT and RAJUK, listing roles like Town Planner, Deputy Team Leader, Team Leader, and Project Director with signatures.

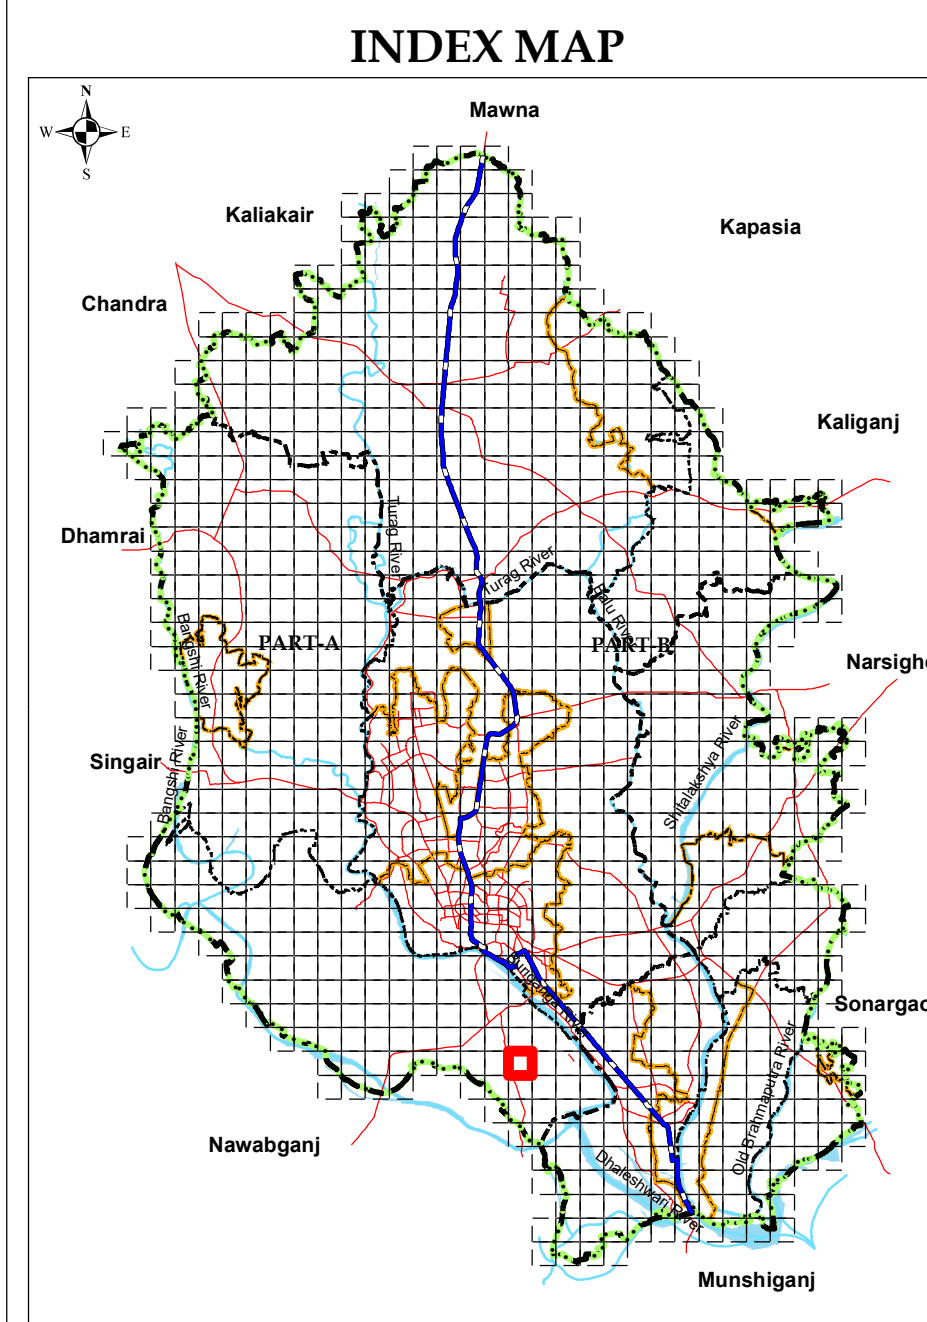

SHEET INDEX table showing a grid of sheets (106-1 to 107-1) with sheet 106-3 highlighted in red.

